
 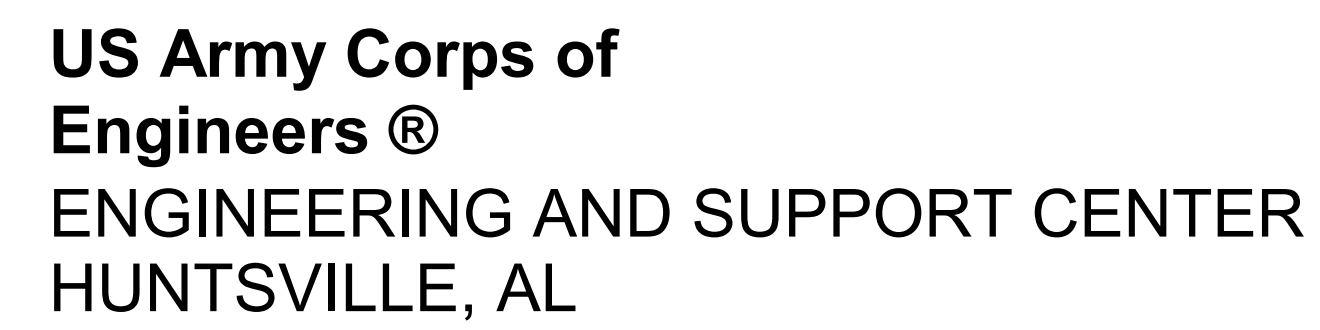



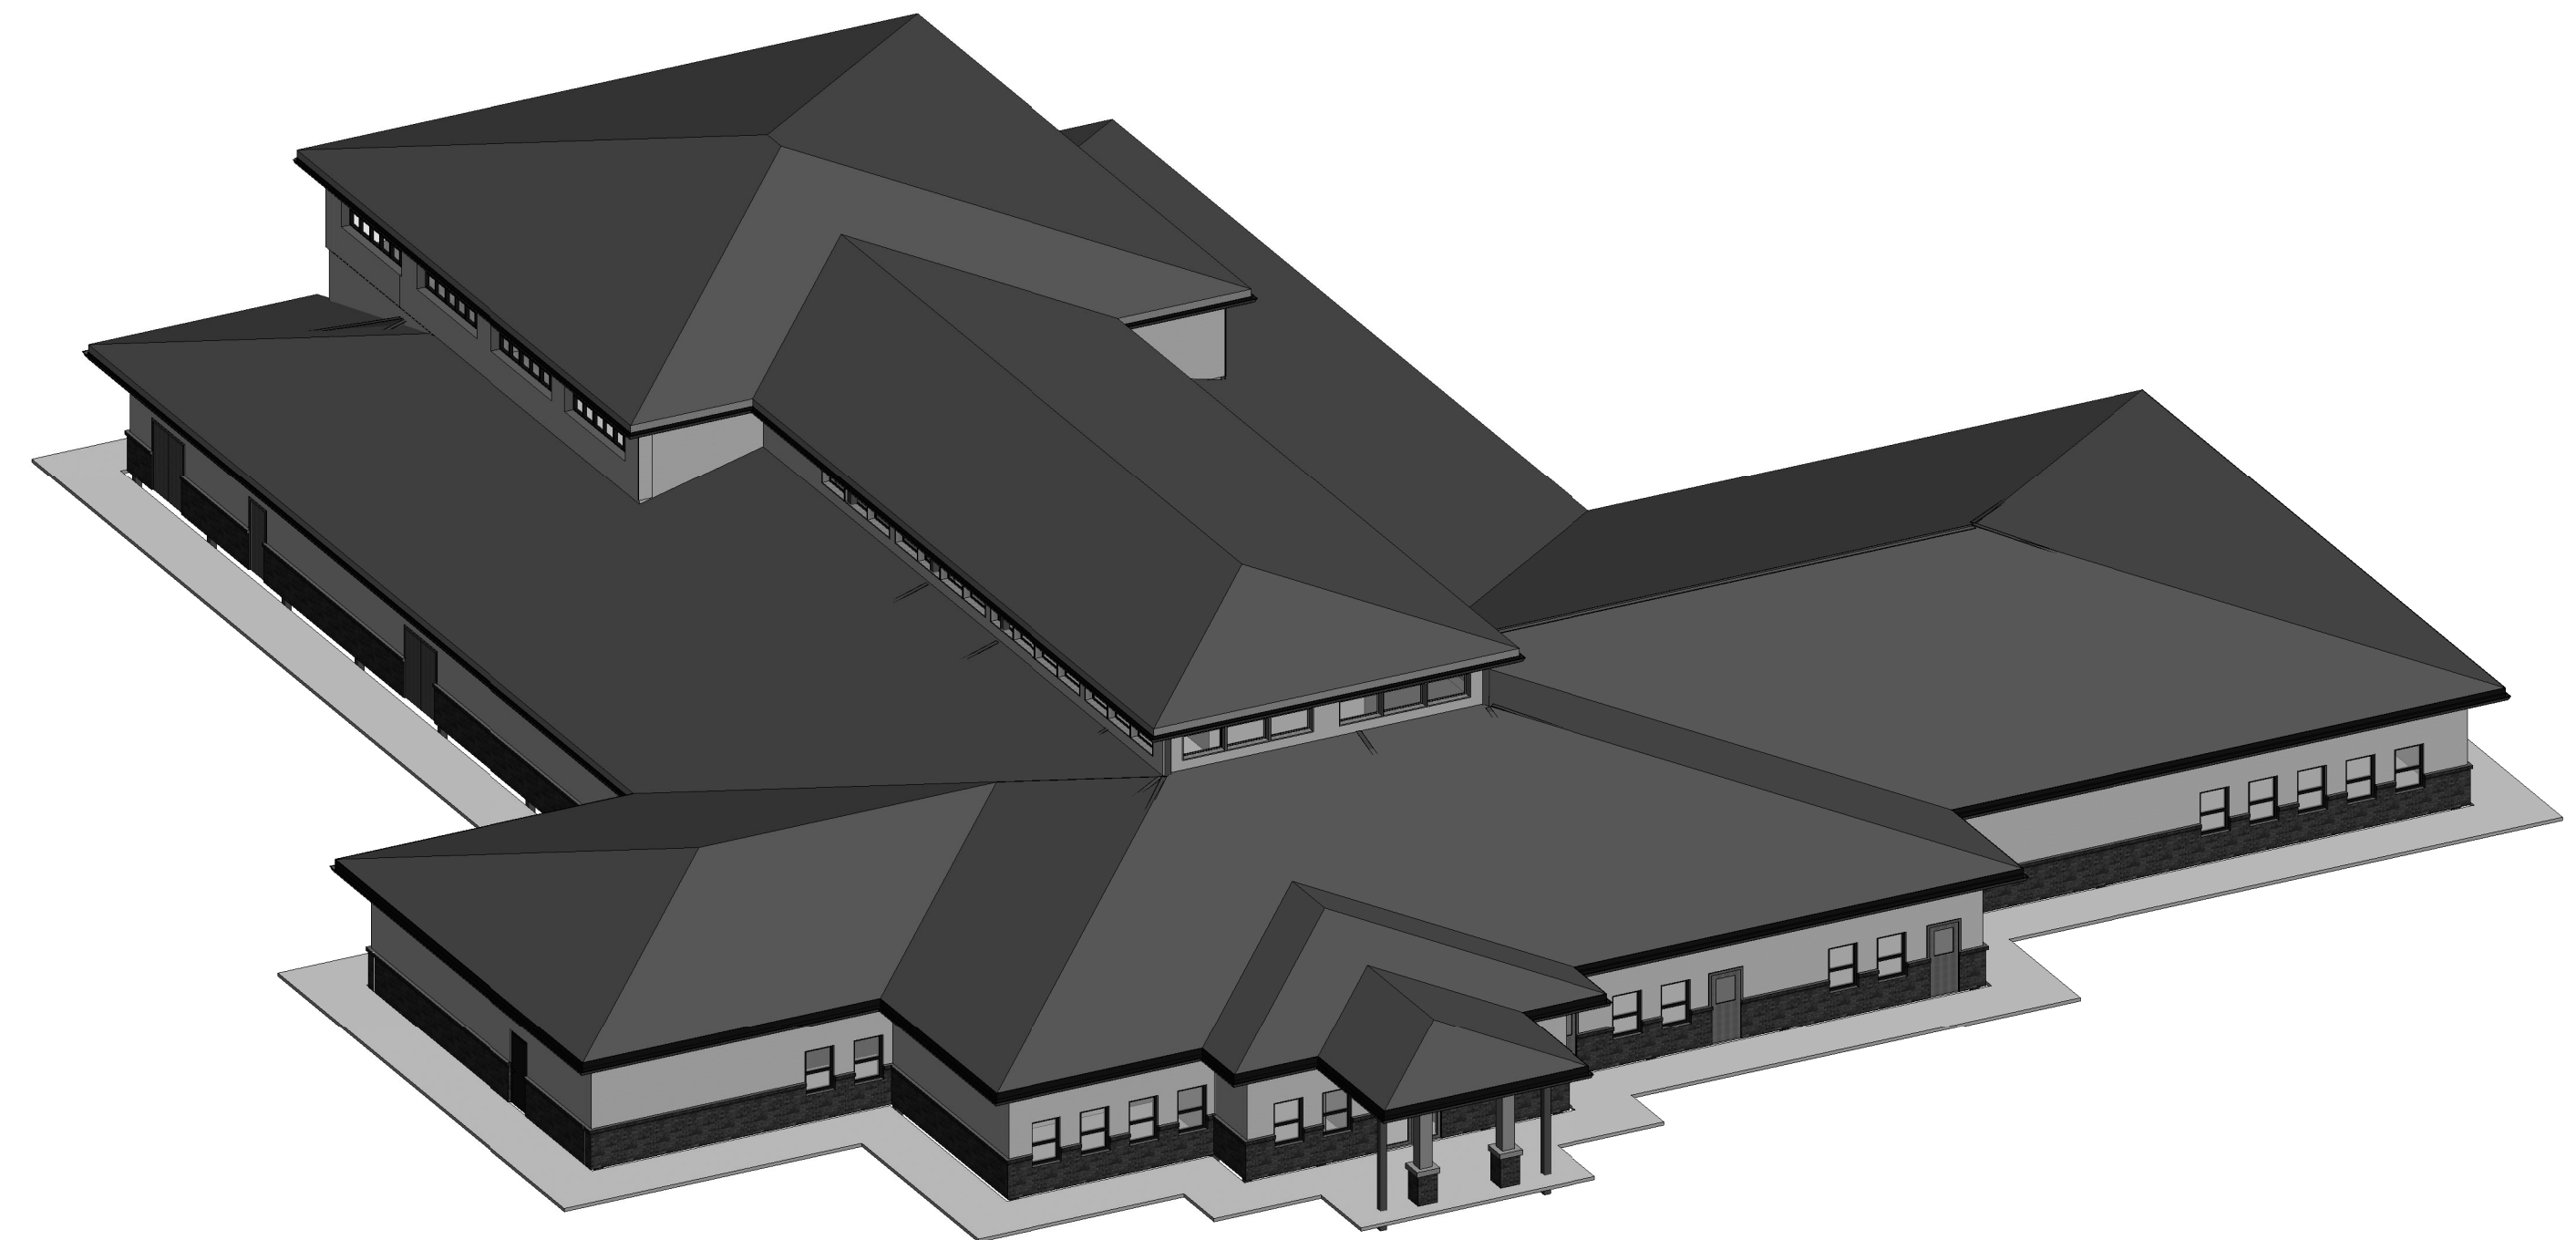

CENTER OF STANDARDIZATION
CATEGORY CODE: 74016

CONTRACT NUMBER : N/A
SOLICITATION NUMBER : N/A


PUBLISHED: SEPTEMBER 2022



[illegible]

ENGINEERING AND SUPPORT CENTER	475 QUALITY CIRCLE HUNTSVILLE, AL 35806	Designer:	CID BY:	SOLICITATION NO.:
		Drawn by:	Checked:	N/A
		Author:		
		SBMT BY:	PLOT DATE:	CONTRACT NO.:
		Approved:	9/21/2022	N/A
		PLOT SCALE:	1/26:17 PM	CATEGORY CODE:
		SIZE: D	FILE NAME:	
		22" x 34"		

STANDARD DESIGN, LARGE
6 - 10 YEARS OLD

PLATE
REFERENCE
NUMBER
A-000
HEET

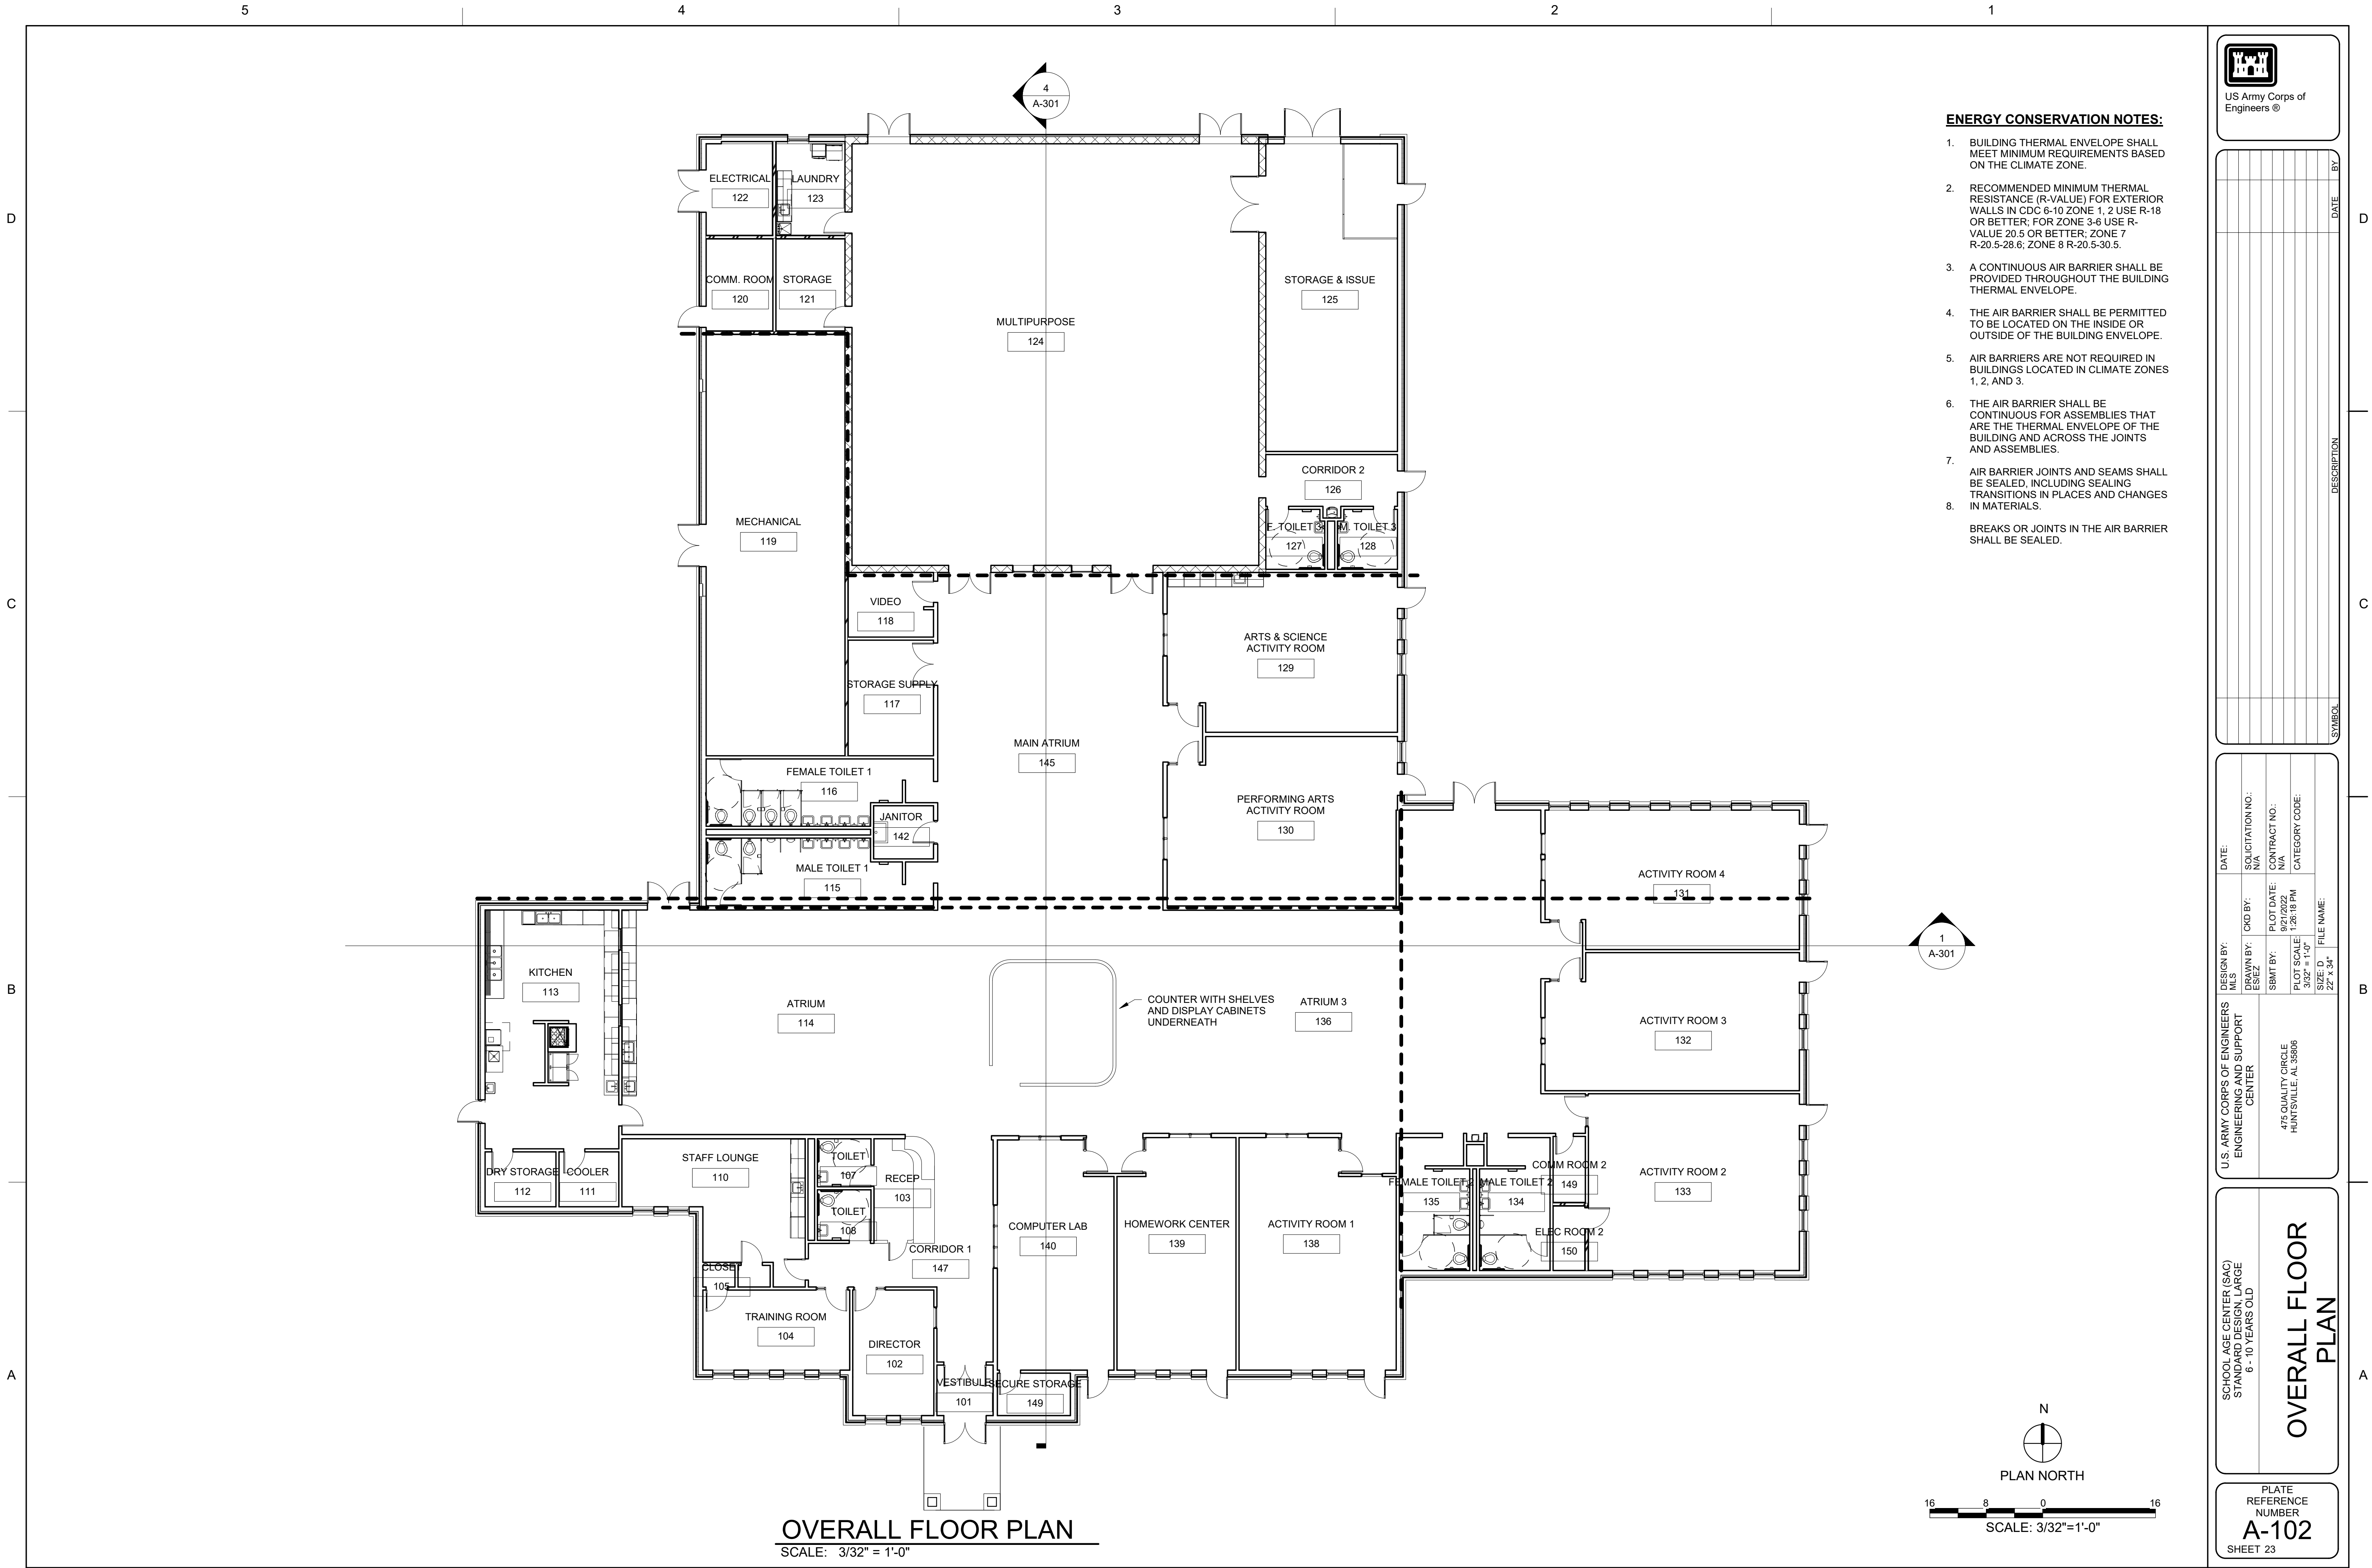

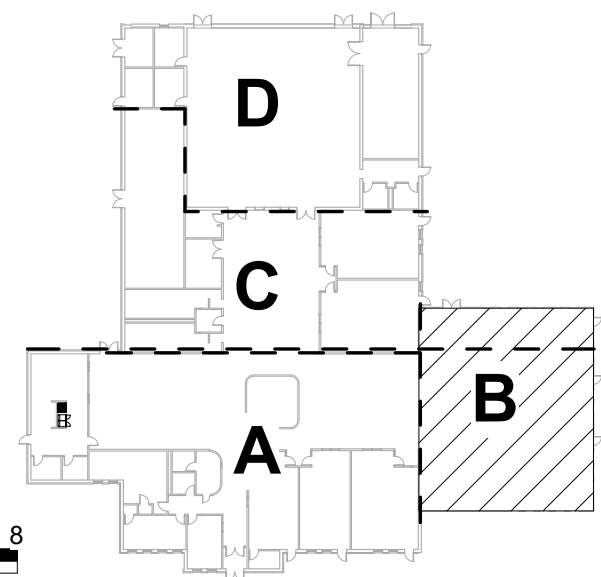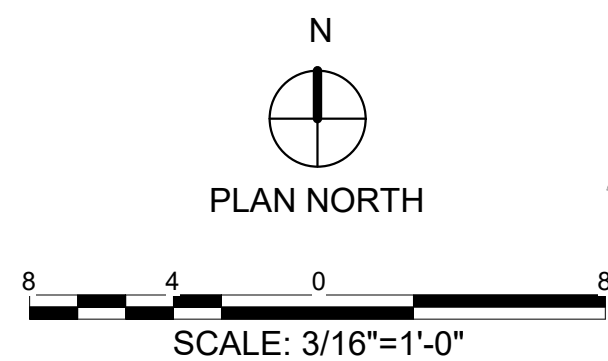


US Army Corps of Engineers®

U.S. ARMY CORPS OF ENGINEERS ENGINEERING AND SUPPORT CENTER	DESIGN BY:	DATE:
	M/S	
	DRAWN BY:	SOLICITATION NO.:
	E/SEZ	N/A
	CKD BY:	
475 QUALITY CIRCLE HUNTSVILLE, AL 35806	SMIT BY:	CONTRACT NO.:
		N/A
	PLOT DATE:	
	9/21/2022	1:26:21 PM
	PLOT SCALE:	CATEGORY CODE:

SCHOOL AGE CENTER (SAC)
STANDARD DESIGN, LARGE
6 - 10 YEARS OLD

PLATE
REFERENCE
NUMBER
A-104
SHEET 25

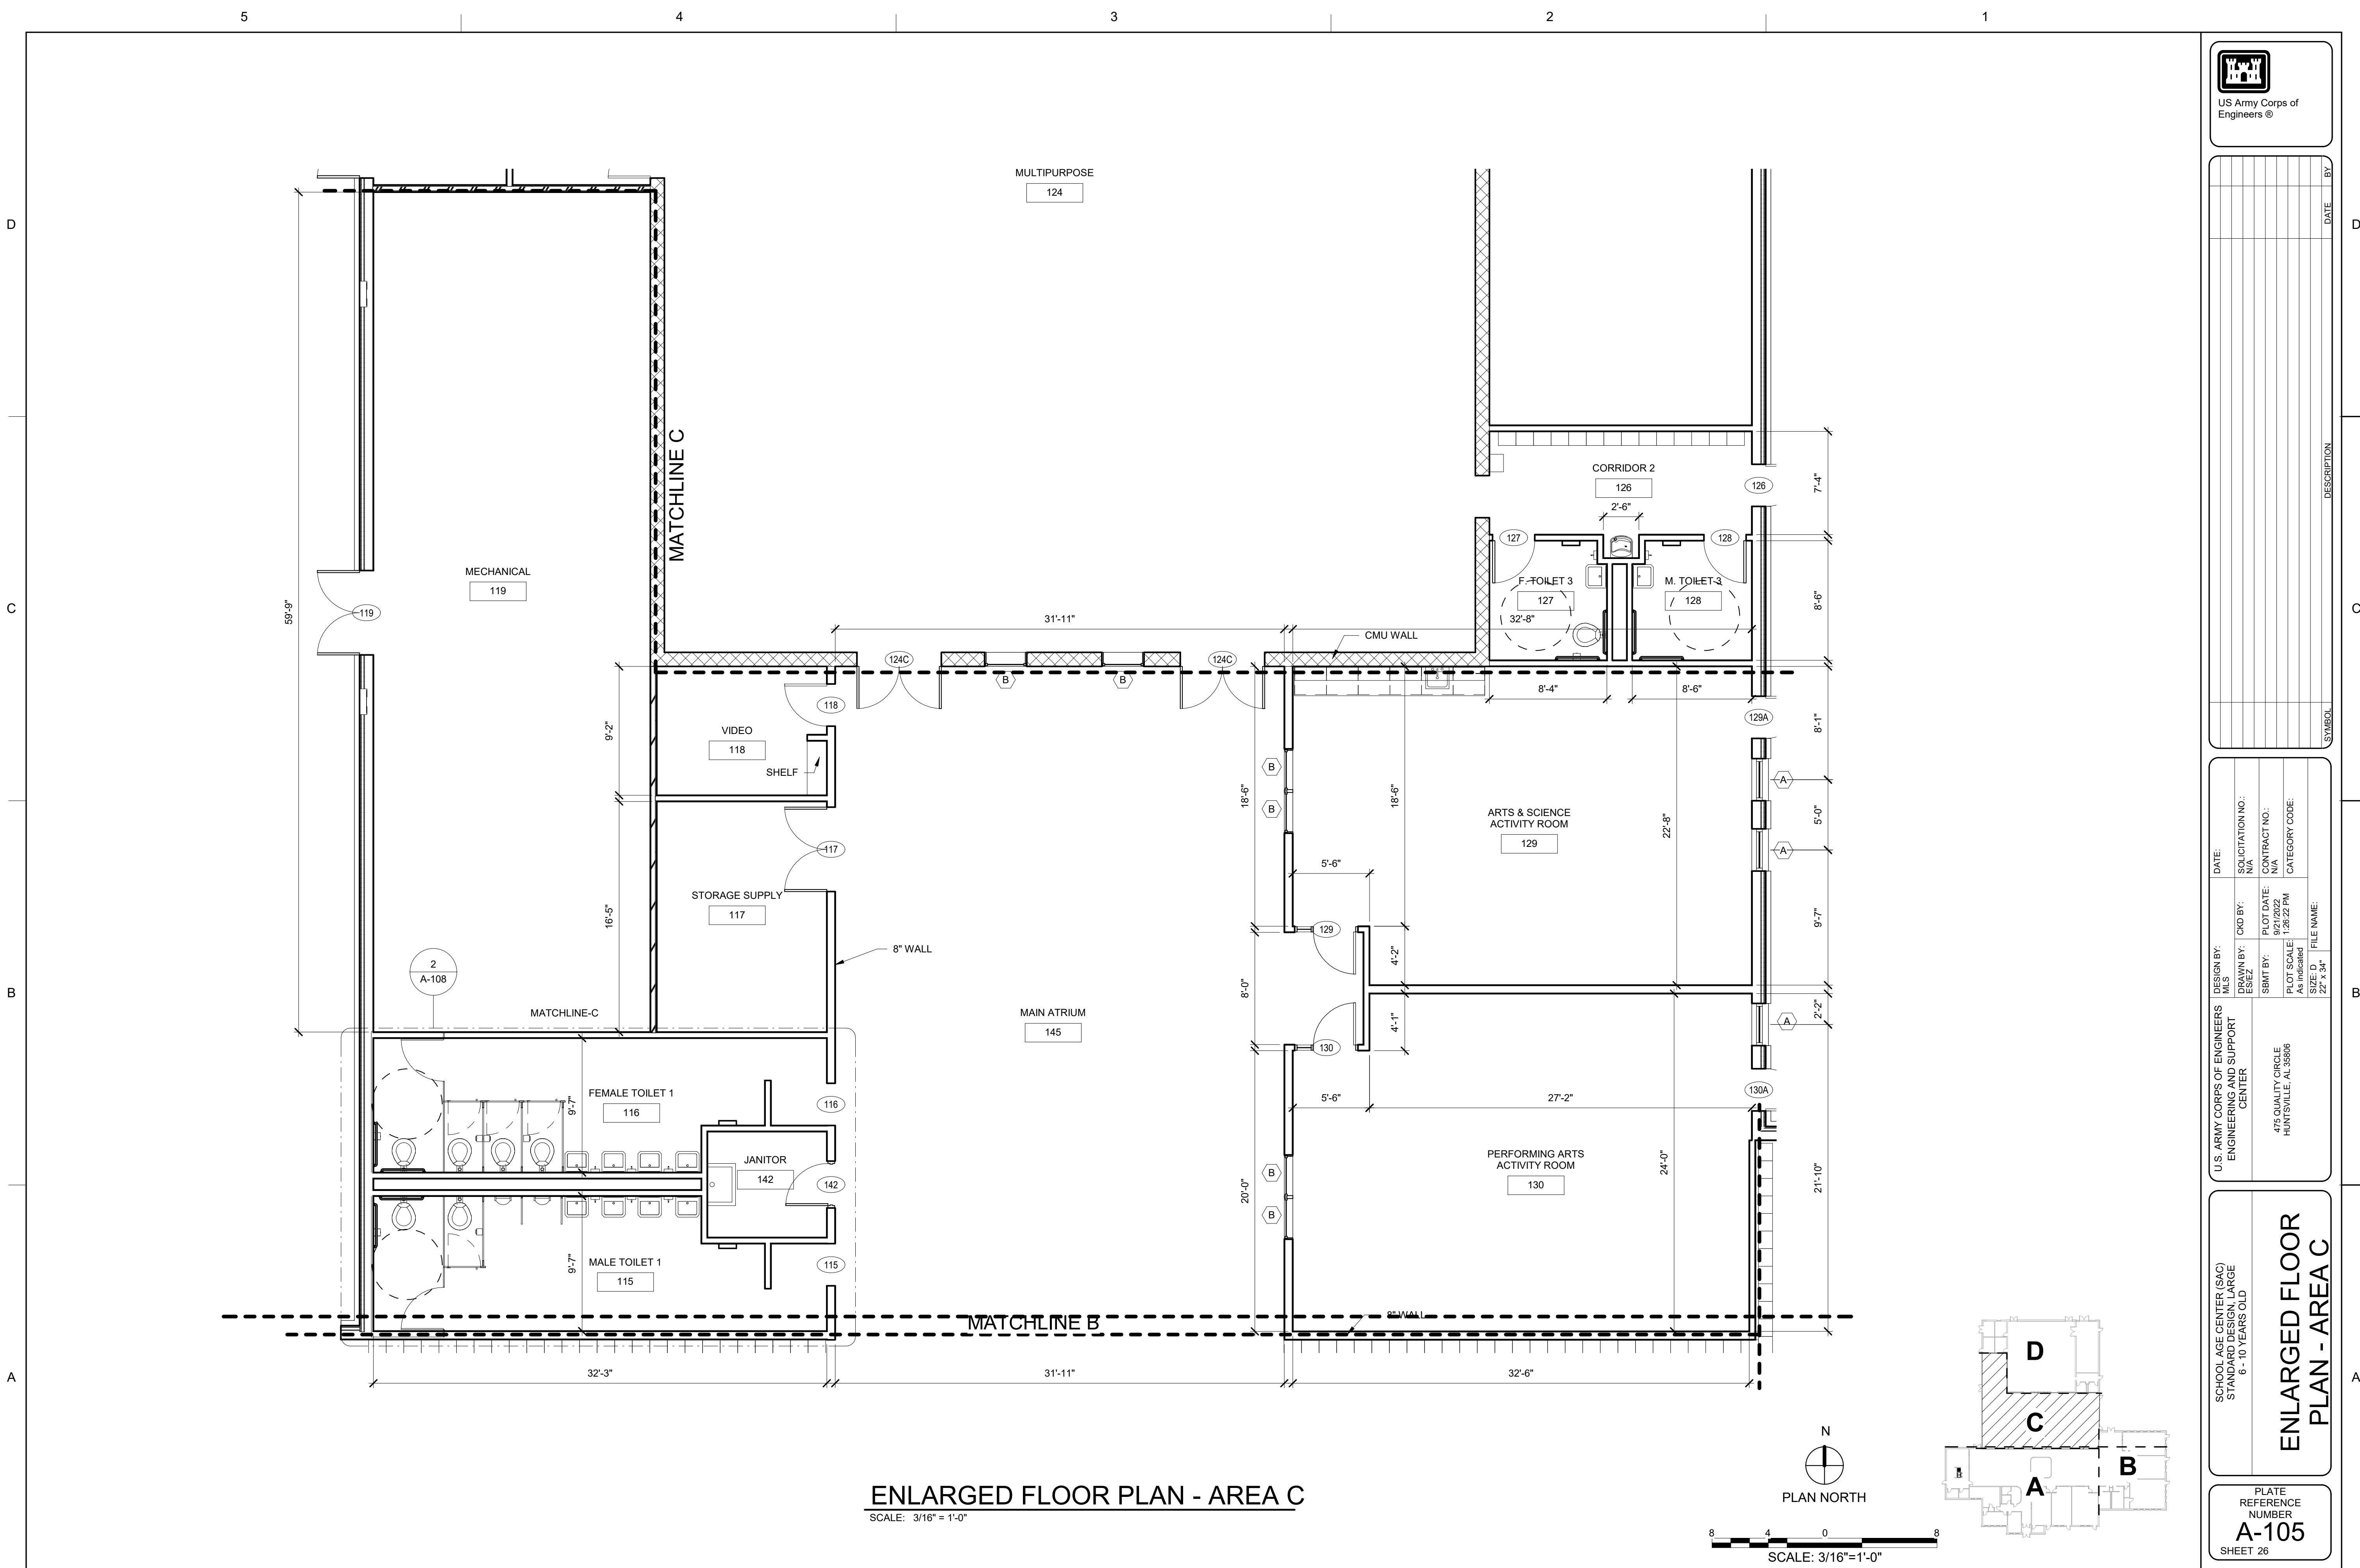

US Army Corps of Engineers®




DESIGN BY:	DATE:	SOLICITATION NO.:
DESIGNED BY:	N/A	N/A
CHK BY:	N/A	N/A
ESK BY:	N/A	N/A
SEMT BY:	9/21/2022	CONTRACT NO.:
PLOT SCALE:	1:2522 PM	CATEGORY CODE:
FILE NAME:	22' x 34'	

SCHOOL AGE CENTER (SAC)
STANDARD DESIGN, LARGE
6-10 YEARS OLD

**ENLARGED FLOOR
PLAN - AREA C**

PLATE
REFERENCE
NUMBER
A-105

 
SHEET 26

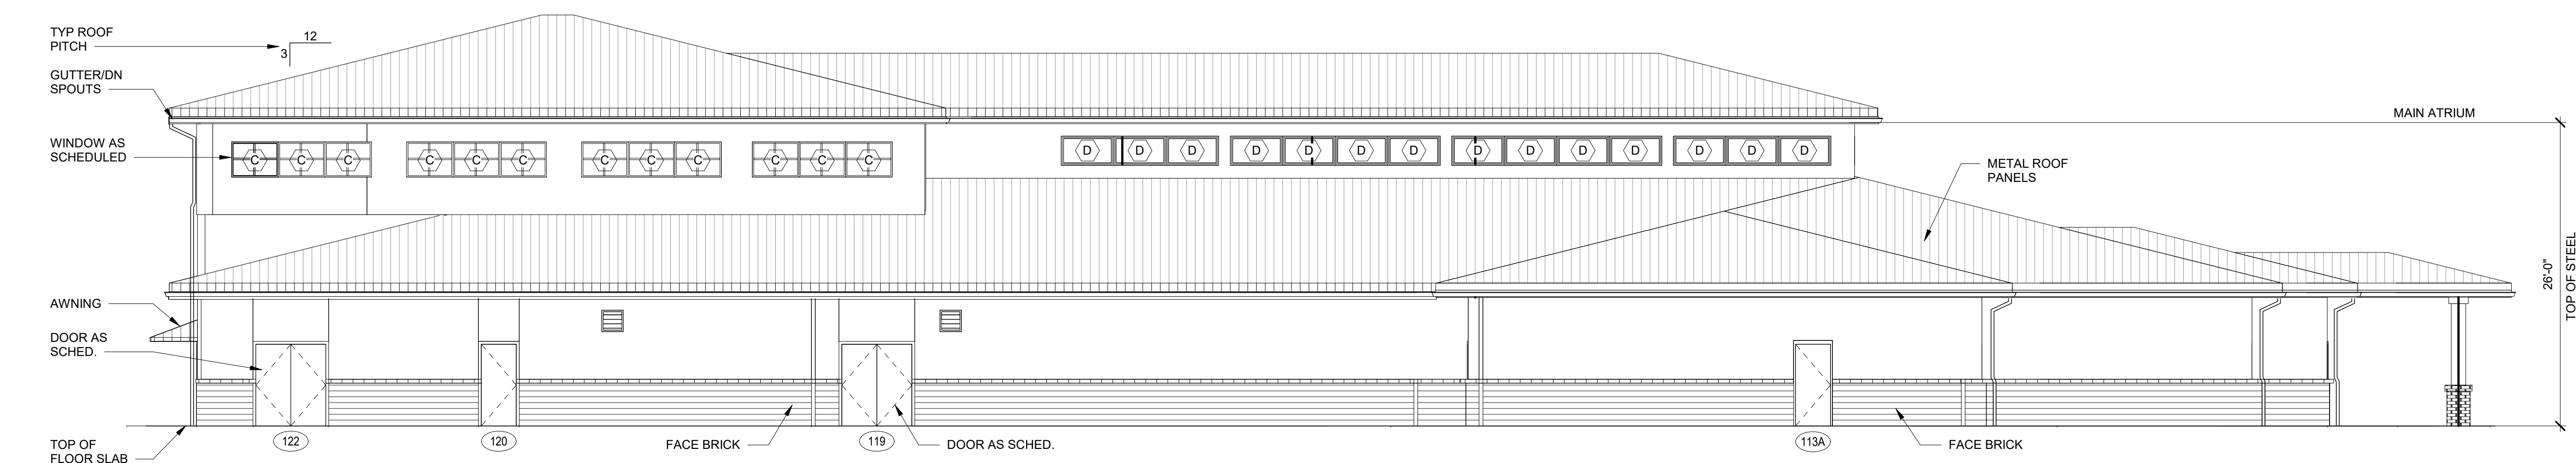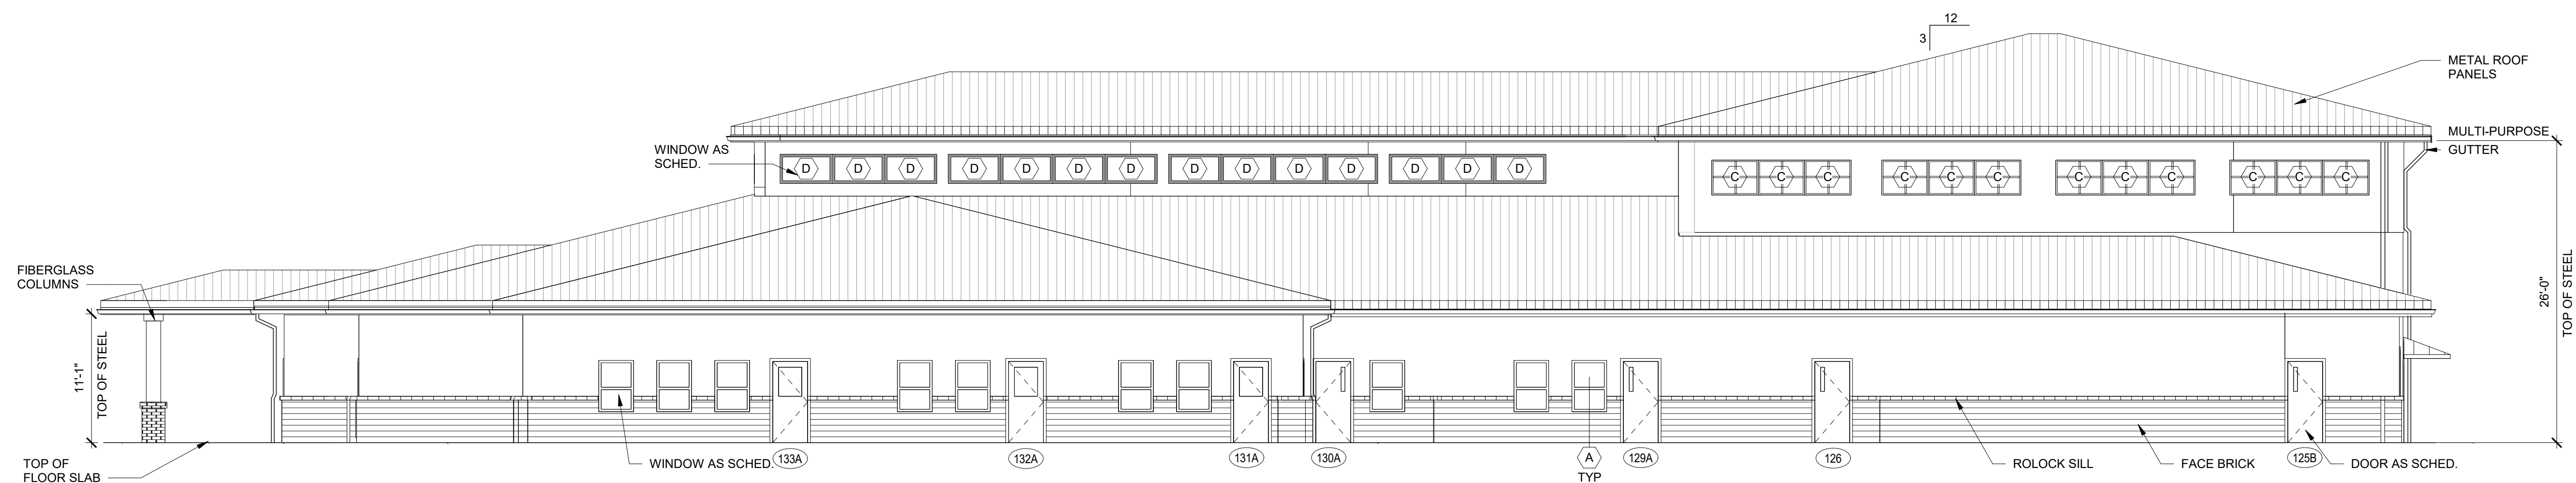[illegible]


U.S. ARMY CORPS OF ENGINEERS ENGINEERING AND SUPPORT CENTER	DESIGN BY: M/S	DATE:
	DRAWN BY: E/SEJZ	CHKD BY: N/A
	SBMT BY:	CONTRACT NO.: N/A
	PLOT SCALE: 1/8" = 1'-0"	CATEGORY CODE:
	SIZE: D	FILE NAME:
	22" x 34"	

SCHOOL AGE CENTER (SAC)
STANDARD DESIGN, LARGE
6 - 10 YEARS OLD


PLATE
REFERENCE
NUMBER
A-201
SHEET 32

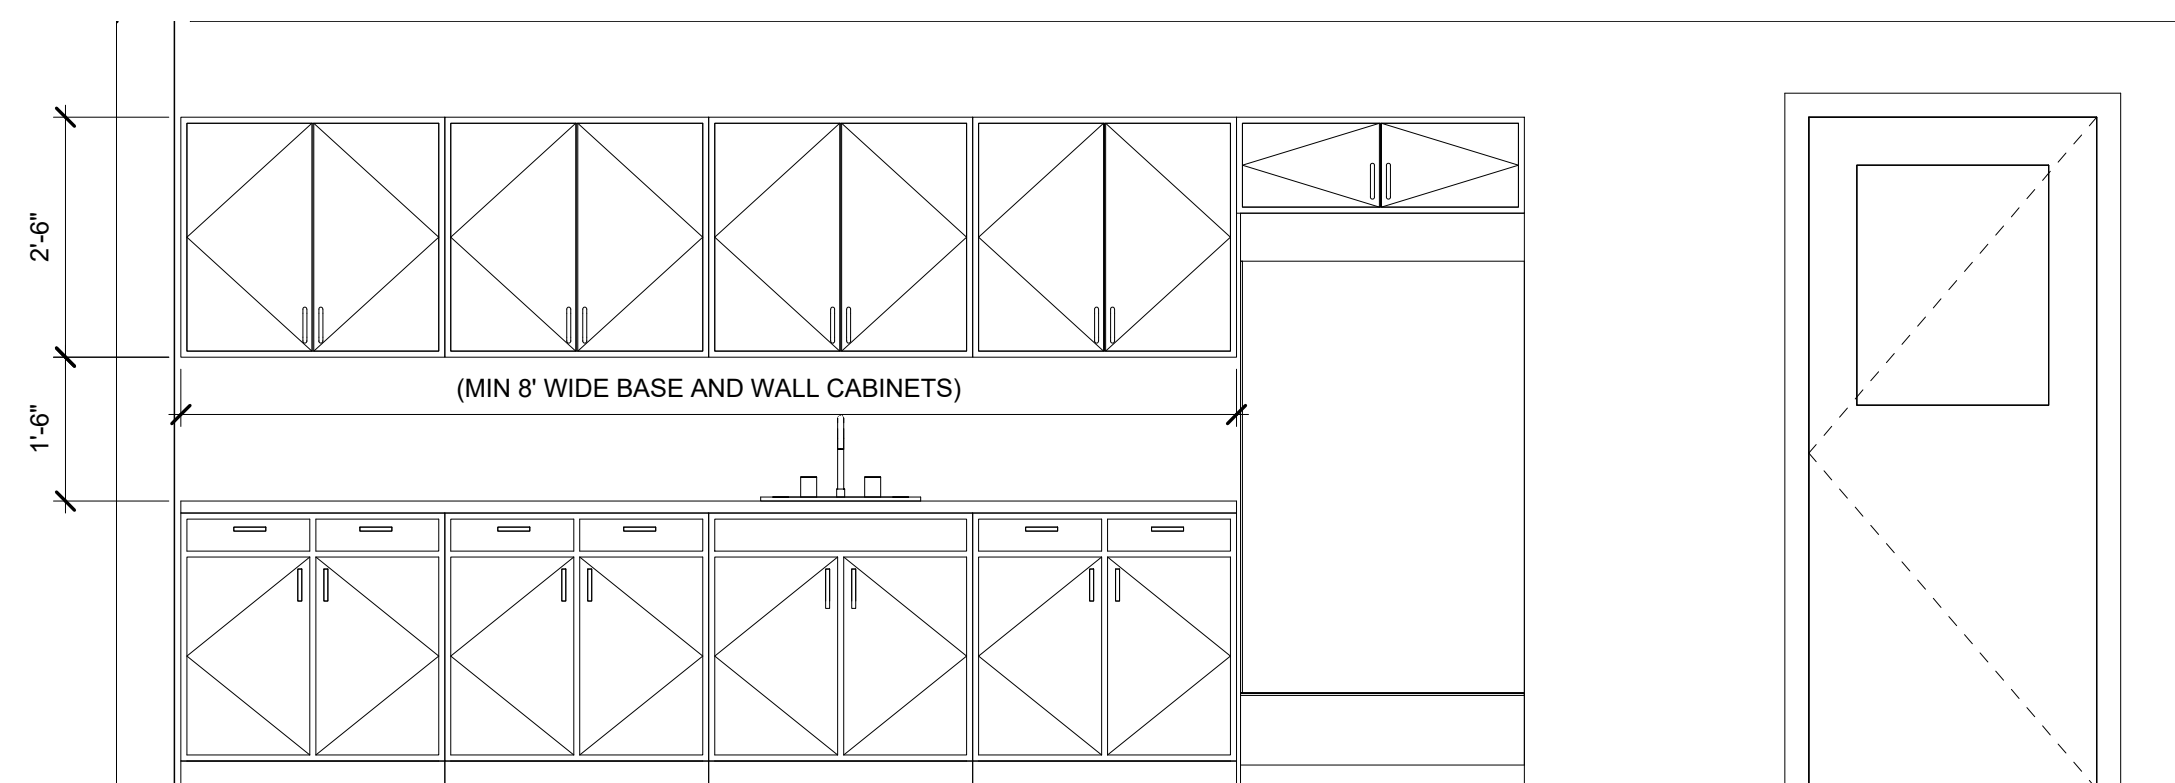


1 STAFF LOUNGE
A-108 SCALE: 1/2" = 1'-0"

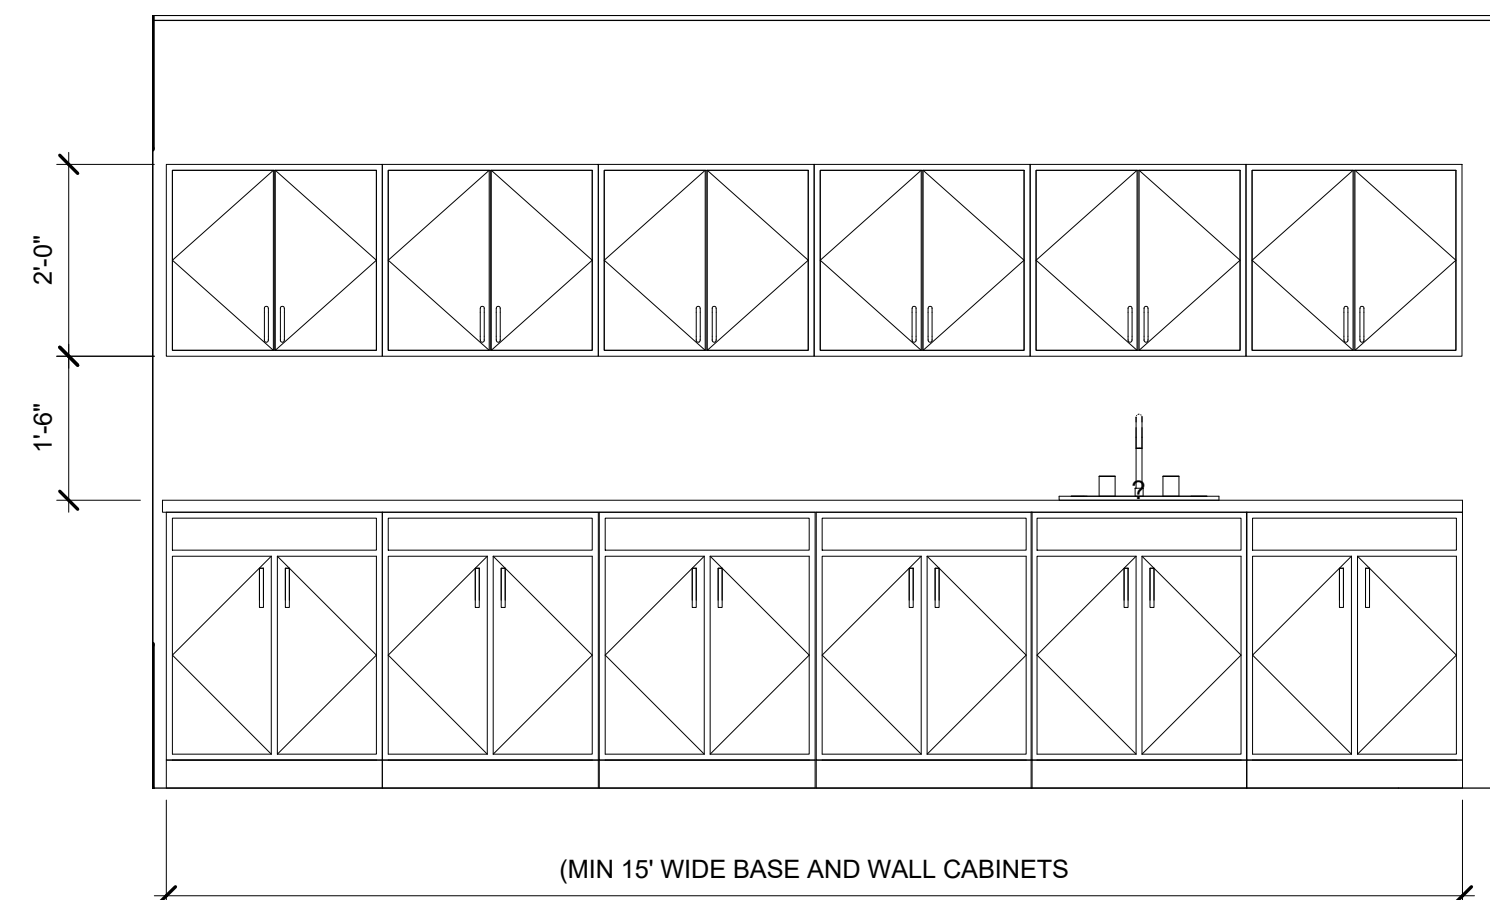


2 ARTS & SCIENCE
SCALE: 1/2" = 1'-0"

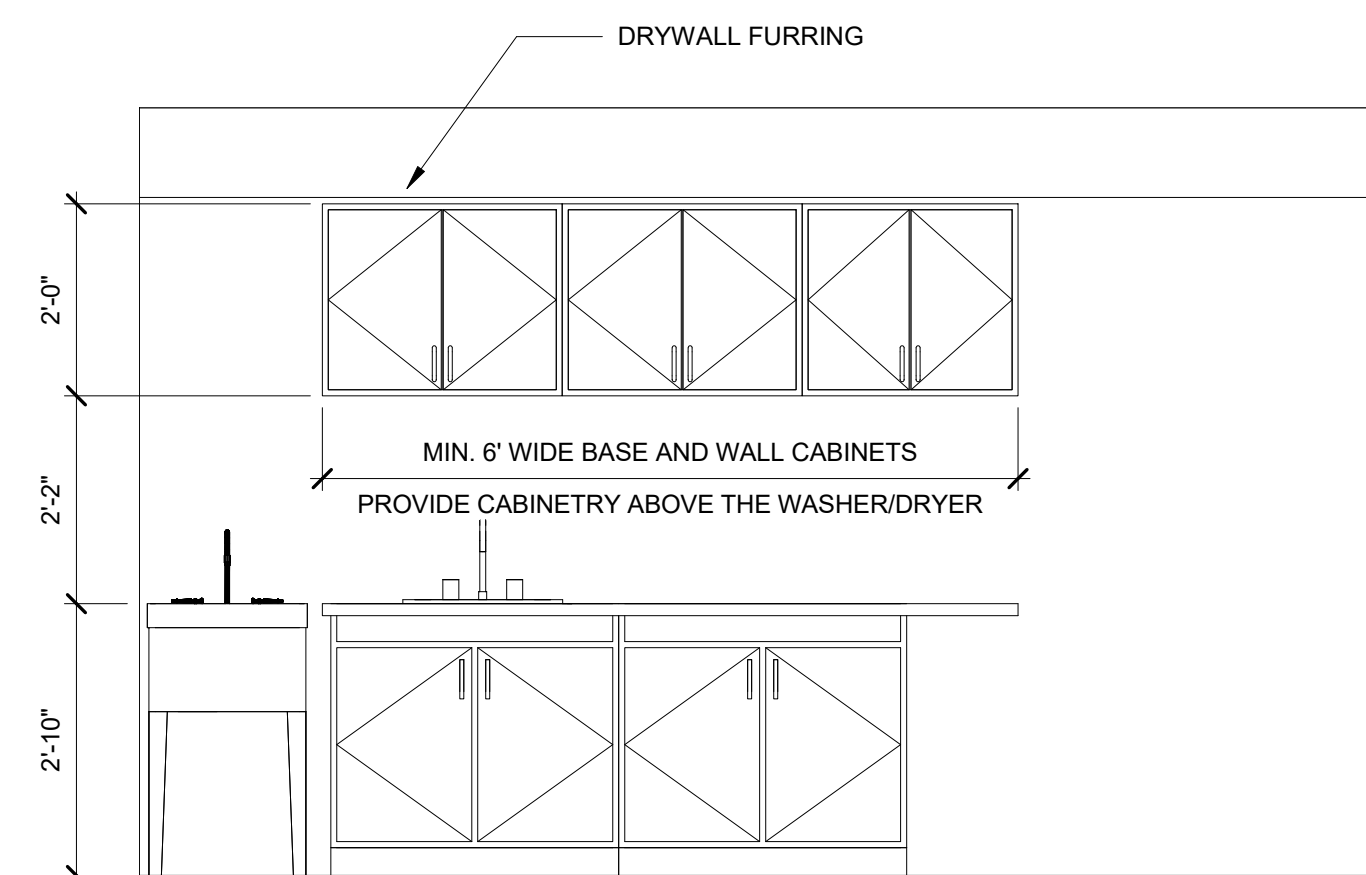


3 LAUNDRY ROOM
SCALE: 1/2" = 1'-0"

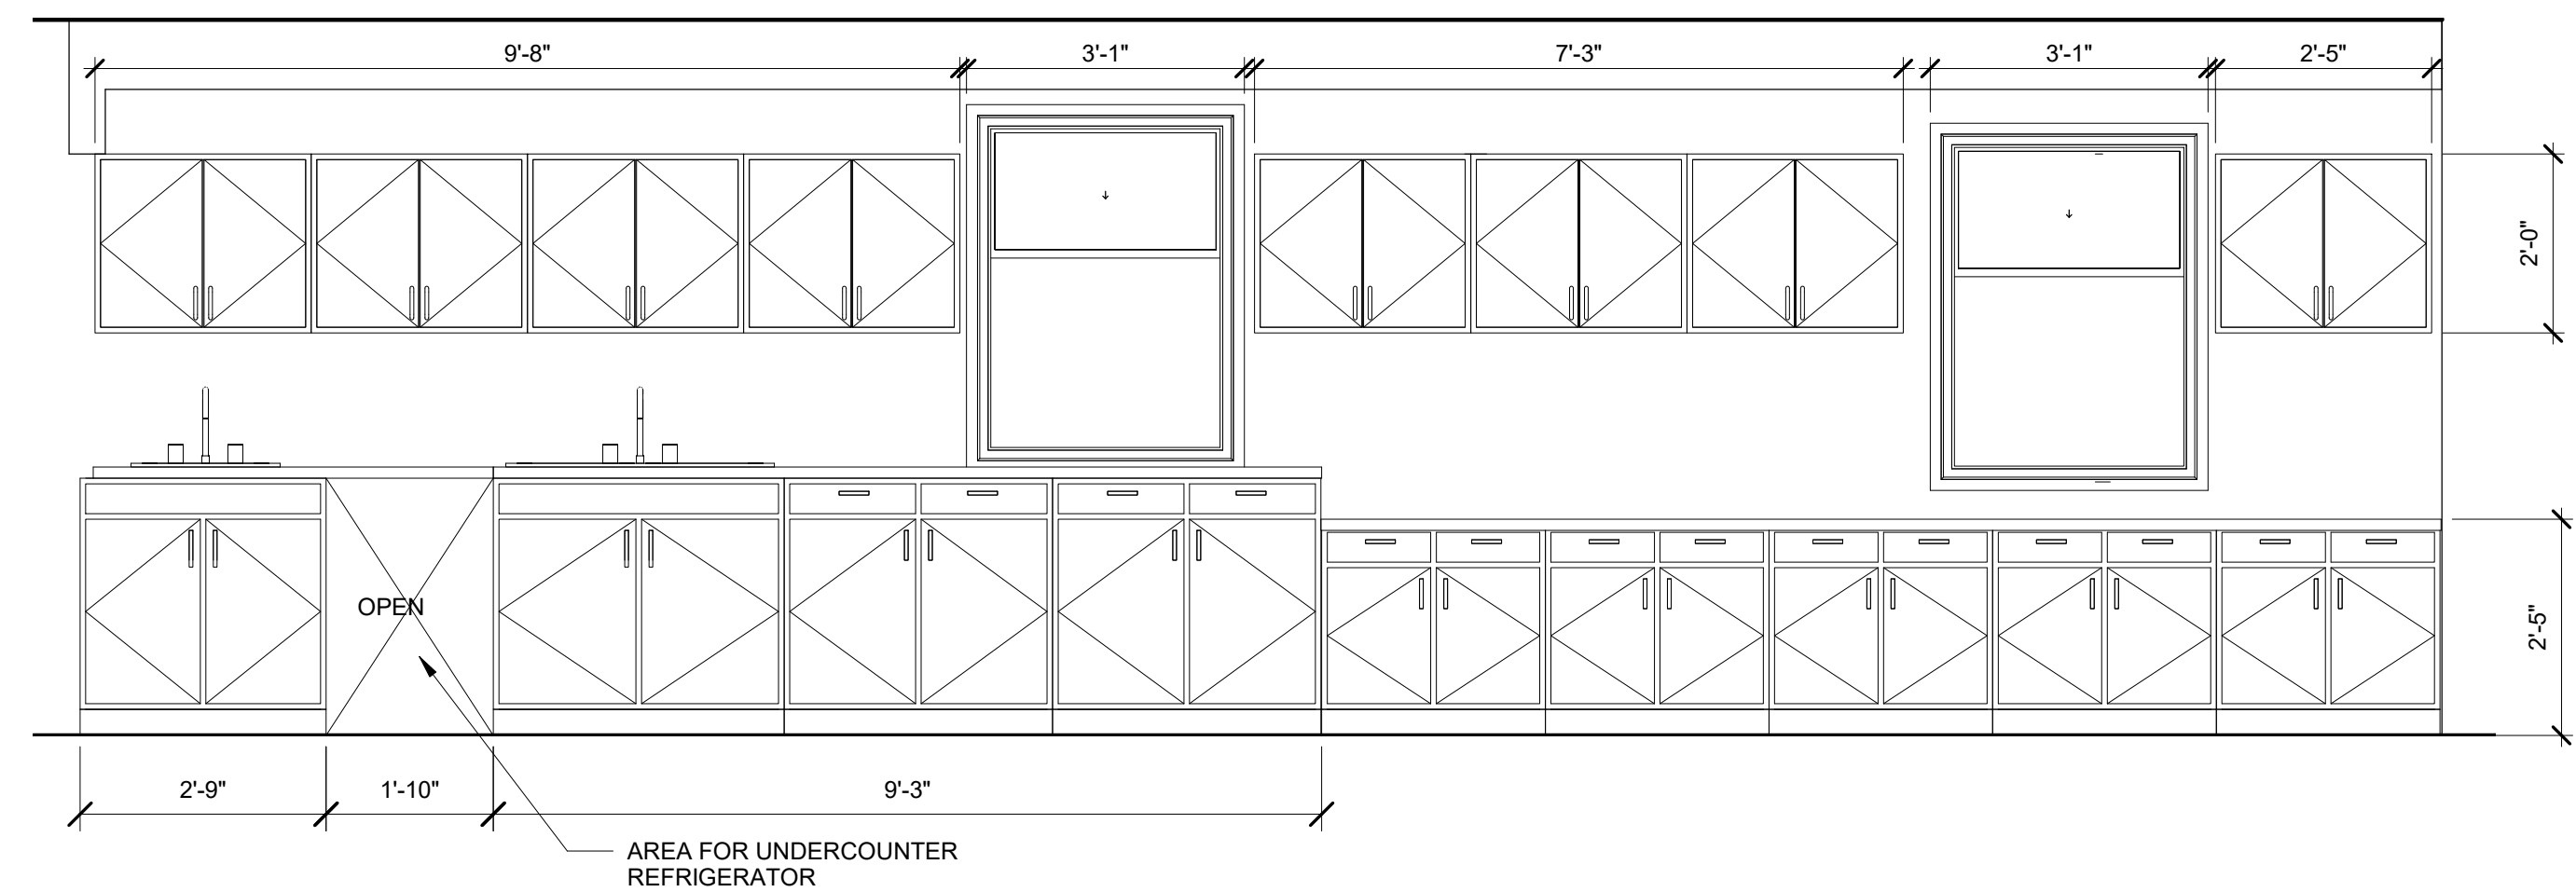


4 ELEVATION- DEMO KITCHEN
SCALE: 1/2" = 1'-0"

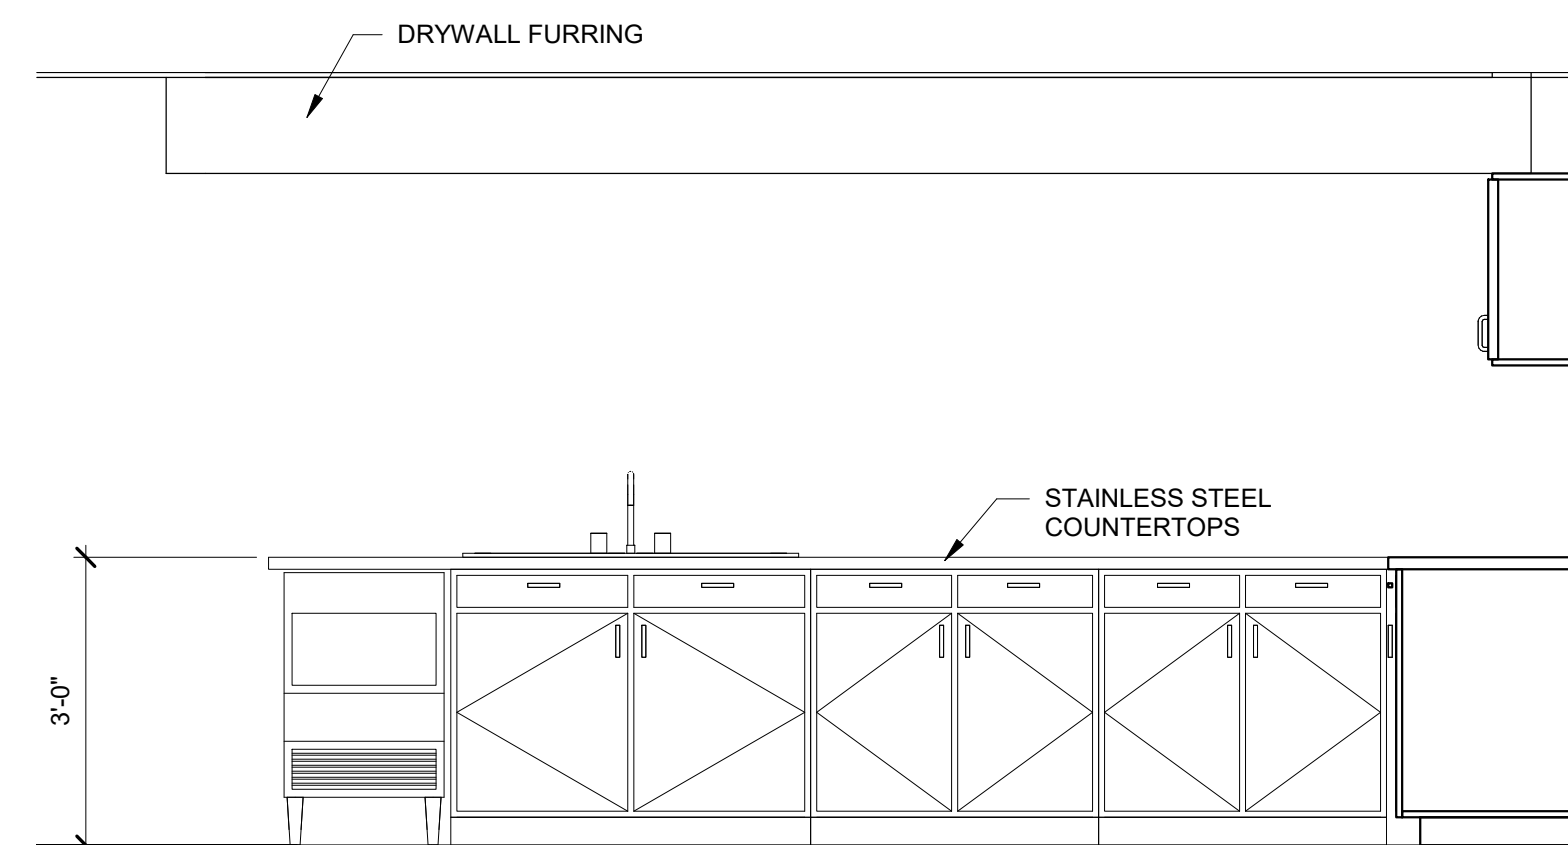

5 KITCHEN
A-107 SCALE: 1/2" = 1'-0"

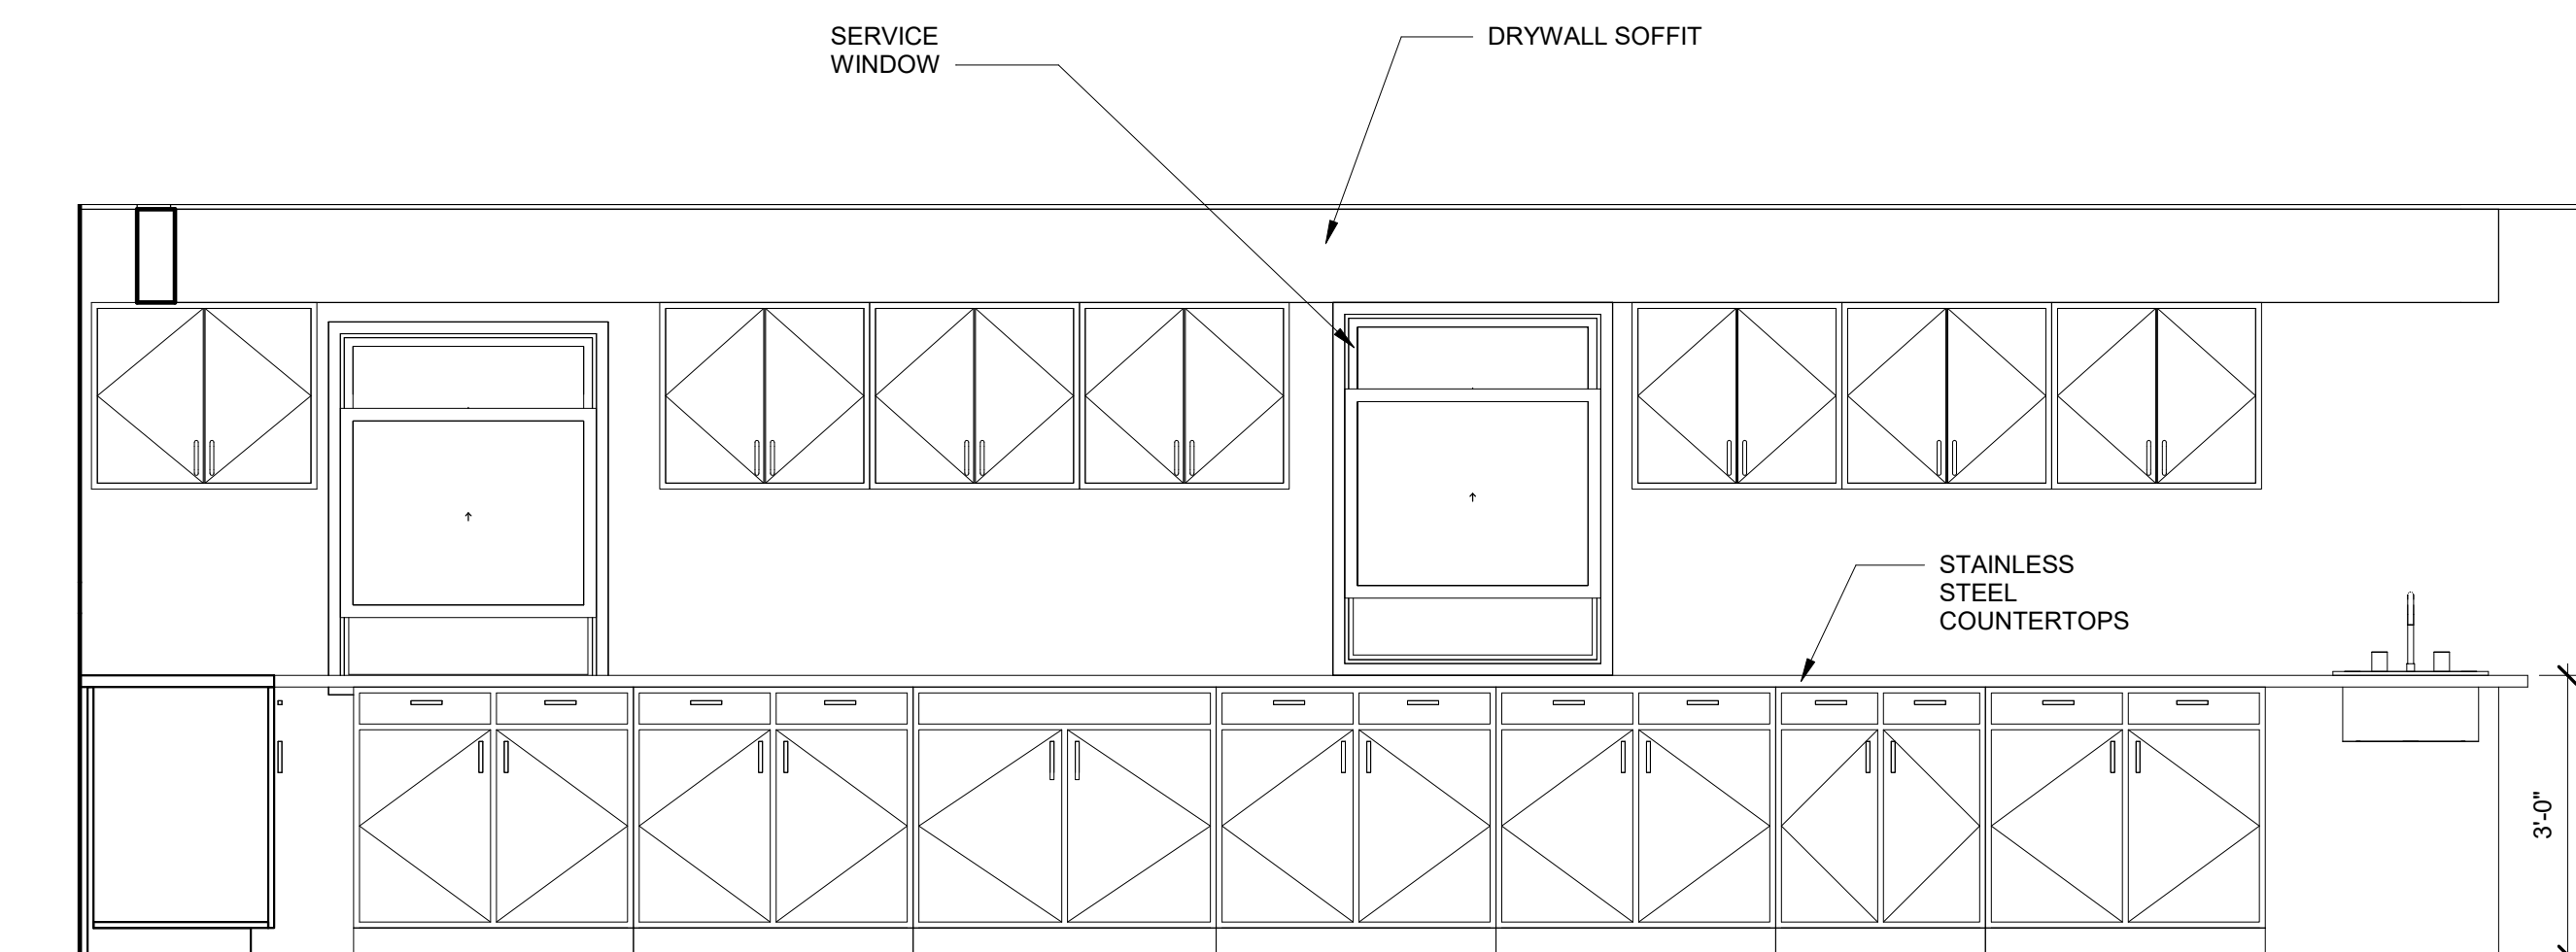

6 ELEVATION-KITCHEN
SCALE: 1/2" = 1'-0"

 

US Army Corps of
Engineers®


[illegible]


MLS	DRAWN BY: ESEZ	CKD BY:	SOLICITATION NO.: N/A
	SBMT BY:	PLOT DATE: 9/21/2022	CONTRACT NO.: N/A
	PLOT SCALE: 1/2" = 1'-0"	1:26:35 PM	CATEGORY CODE:
FILE NAME:			
SIZE: D 22" x 34"			

ENGINEERING AND SUPPLY
CENTERSTANDARD DESIGN, LARGE
6 - 10 YEARS OLD

INTERIOR ELEVATIONS

 PLATE
REFERENCE
NUMBER
A-203
T 34



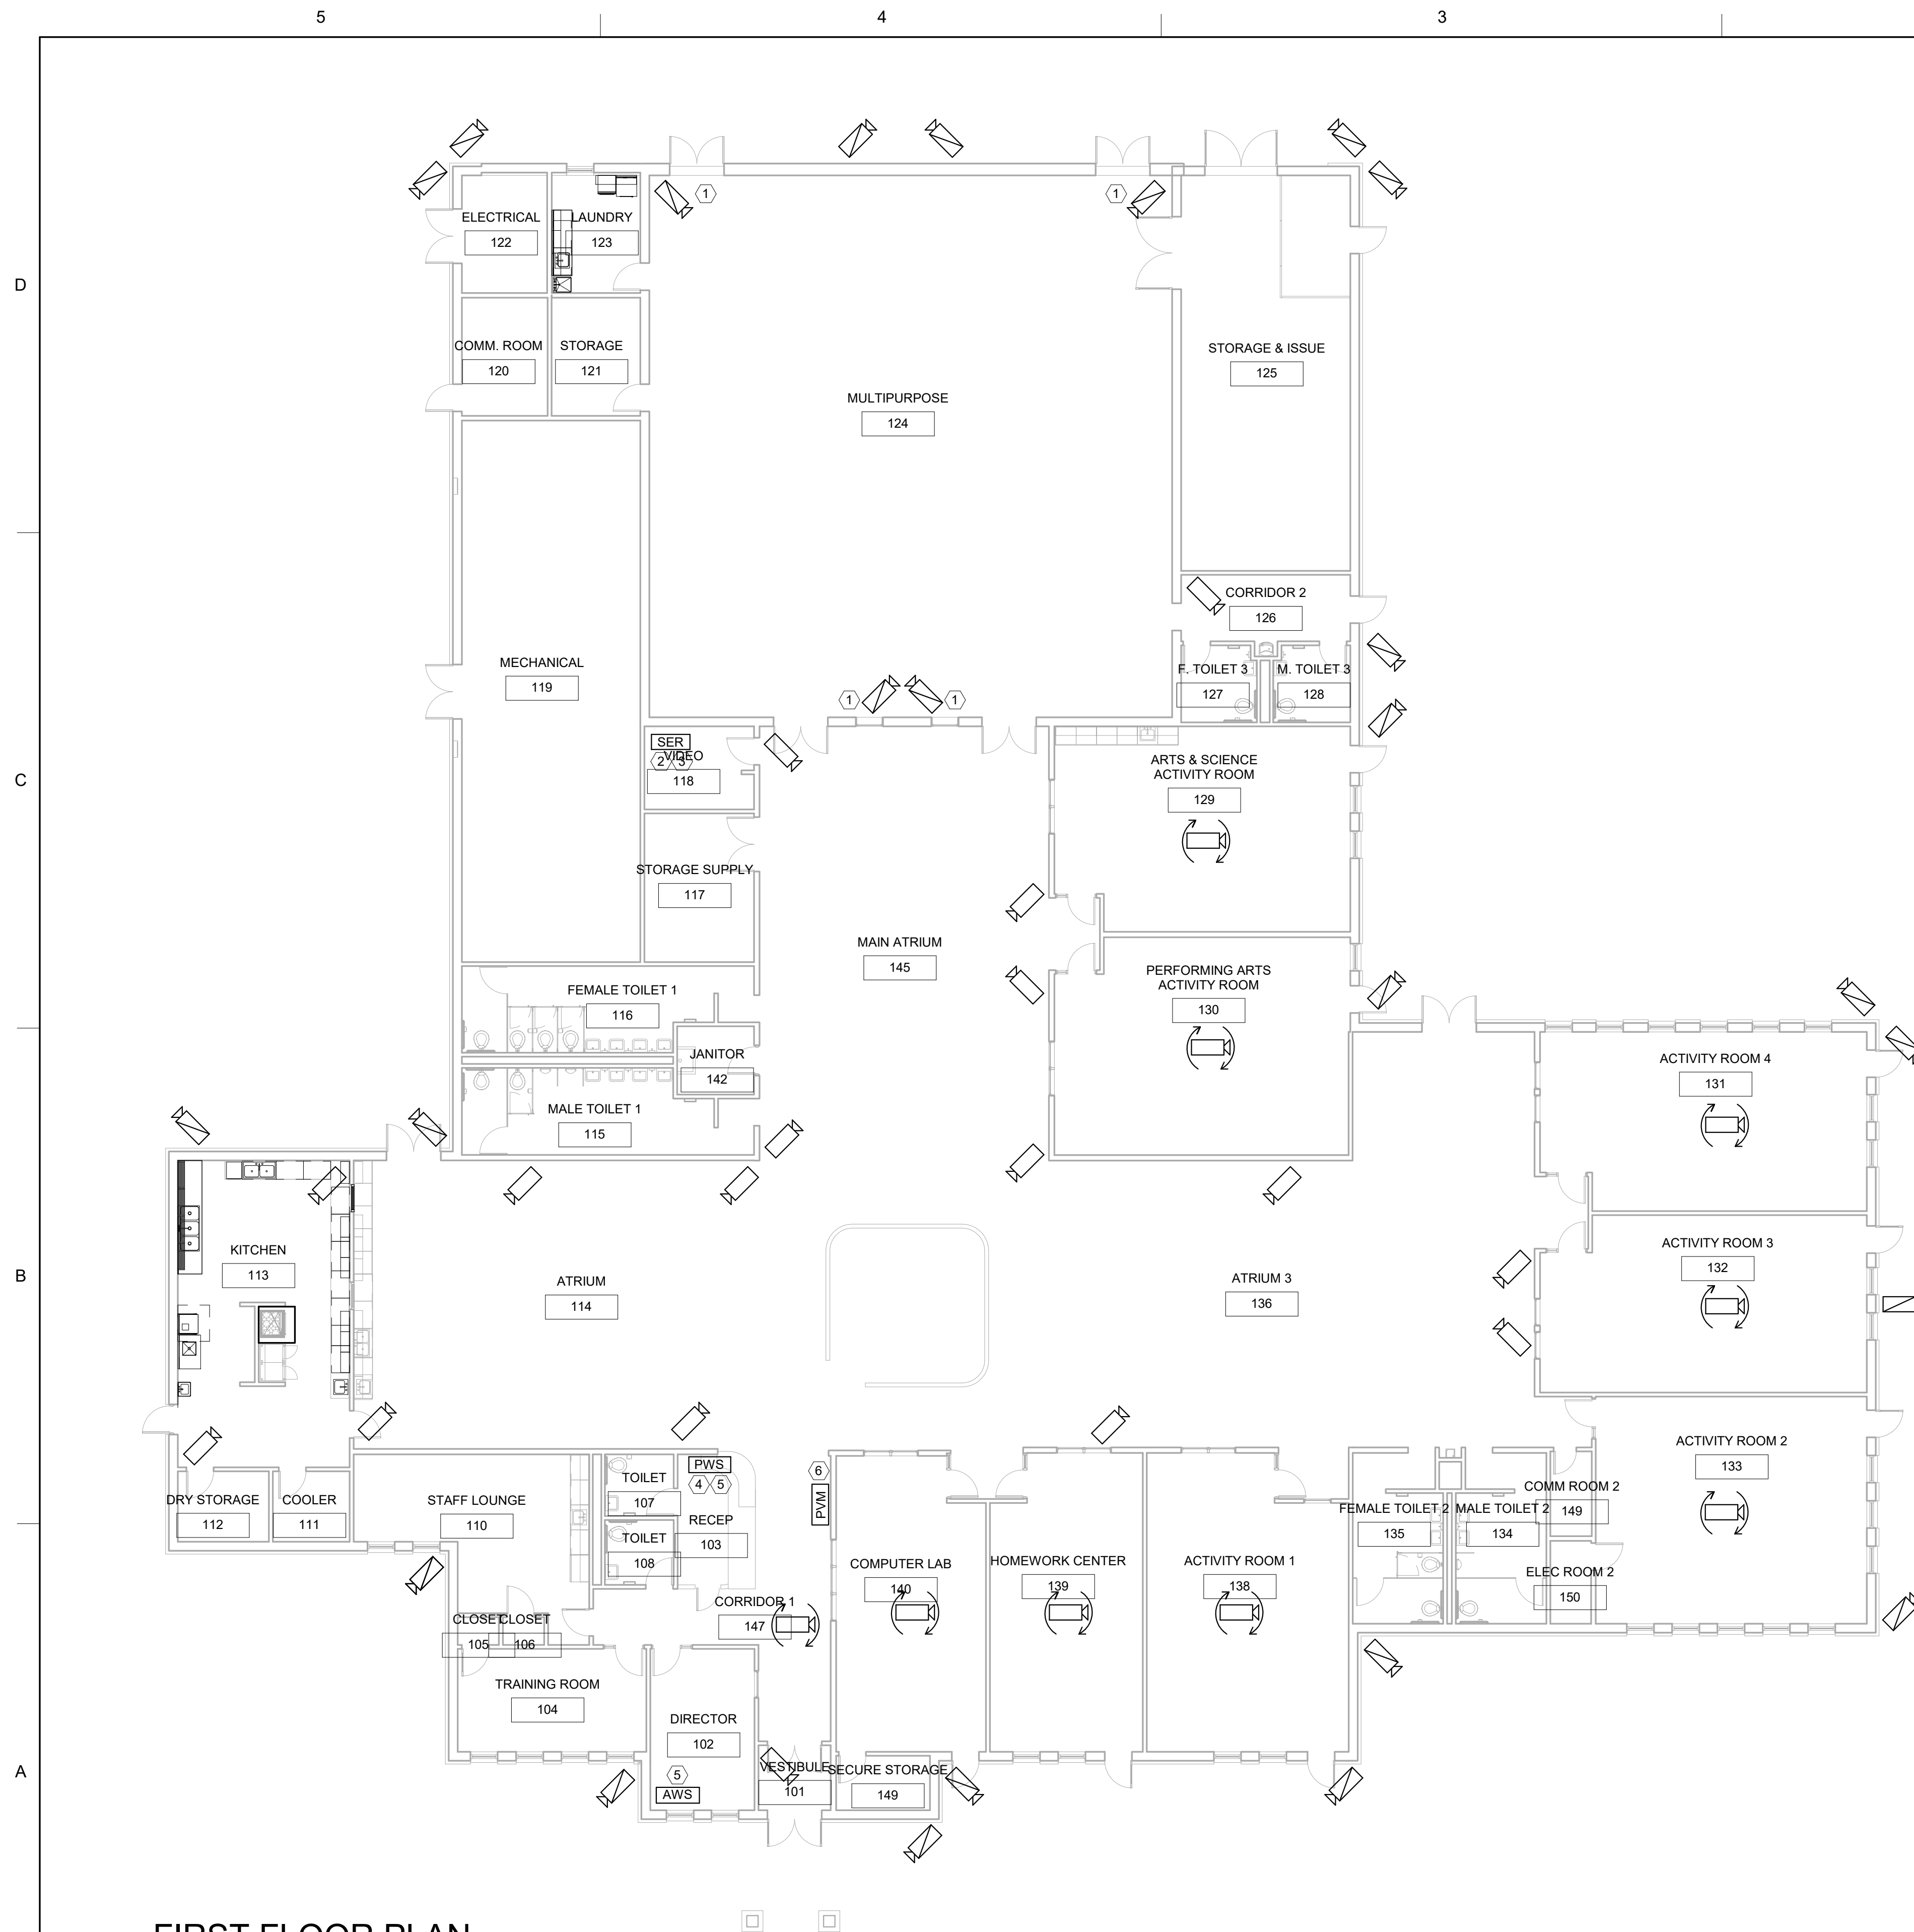

FIRST FLOOR PLAN

GENERAL NOTES:

KEY NOTES:

PLAN SYMBOL KEY:

[illegible]

ENGINEERING AND SUPPORT CENTER	475 QUALITY CIRCLE HUNTSVILLE, AL 35896	DRAWN BY:	QCD BY:	SOLICITATION NO.:
		Author	Checker	N/A
		SBMT BY:	PILOT DATE:	CONTRACT NO.:
		Approver	9/4/2022	N/A
		PLOT SCALE:	1:20,000 PM	CATEGORY CODE:
		Sheet Number		
		FILE NAME:		
		Size	22" x 34"	

STANDARD DESIGN, LARGE
6 - 10 YEARS OLD

SECURITY & MONITORING PLAN

PLATE
REFERENCE
NUMBER
X-101
HEET